

Original Date:
JUNE 22, 2017
 Issue Log
 ISSUED FOR REVIEW 06/30/2017
 ISSUED FOR REVIEW 07/05/2017
 ISSUED FOR REVIEW 07/06/2017
 ISSUED FOR REVIEW 07/08/2017
 ISSUED FOR REVIEW 08/02/2017
 ISSUED FOR PERMIT 08/07/2017
 OWNERS COMMENT 10/05/2017

DRAWN BY: AK
 CHECKED BY: MFK

© COPYRIGHT


FACE UPLIFT AND INTERIOR FINISH OUT
MASJID
 ISLAMIC ASSOCIATION OF FORT WORTH
 AT 4500 COLUMBUS TRAIL, FORT WORTH, TEXAS 76133

This document, whether in hard copy or electronic readable format, is copyrighted and an instrument of services in regard to the project for which it was prepared. This document is not intended or authorized for reuse by any party on extension of such project or any other project. Any reuse, including copying, posting, modifying the document, without written permission from the Designer for the specific purpose intended is a violation of copyright. Copyright © 2017. Unauthorized use of this material may result in civil and/or criminal penalties.

Sheet Number:
A601
 Project Number:
 17-041

NOT FOR CONSTRUCTION

RCP SYMBOL LEGEND		NOTE: NOT ALL SYMBOLS ARE NOT USED.	
	2' x 4' FLUORESCENT LIGHT FIXTURE		INCANDESCENT LIGHT FIXTURE (DOWN LIGHT) W/ BATTERY PACK
	2' x 2' FLUORESCENT LIGHT FIXTURE		2' x 2' RETURN AIR GRILLE
	2' x 4' FLUORESCENT LIGHT FIXTURE		2' x 2' SUPPLY AIR GRILLE
	CEILING MOUNTED EMERGENCY LIGHT W/ BATTERY PACK		EXHAUST AIR GRILLE
	LED LIGHT FIXTURE		WALL MOUNTED EMERGENCY LIGHT BATTERY PACK
	PENDANT LIGHT AS SELECTED		4' DOUBLE TUBE FLUORESCENT LIGHT FIXTURE
	2' x 4' FLUORESCENT PARABOLIC LIGHT FIXTURE		WALL MOUNTED LIGHT FIXTURE
			WALL MOUNTED 2' DOUBLE TUBE FLUORESCENT LIGHT FIXTURE
			EXIT SIGN
			2' x 2' LAY-IN CEILING SYSTEM
			GYP. BD. SOFFIT
			EXPOSED TO STRUCT. ABOVE
			CEILING FAN

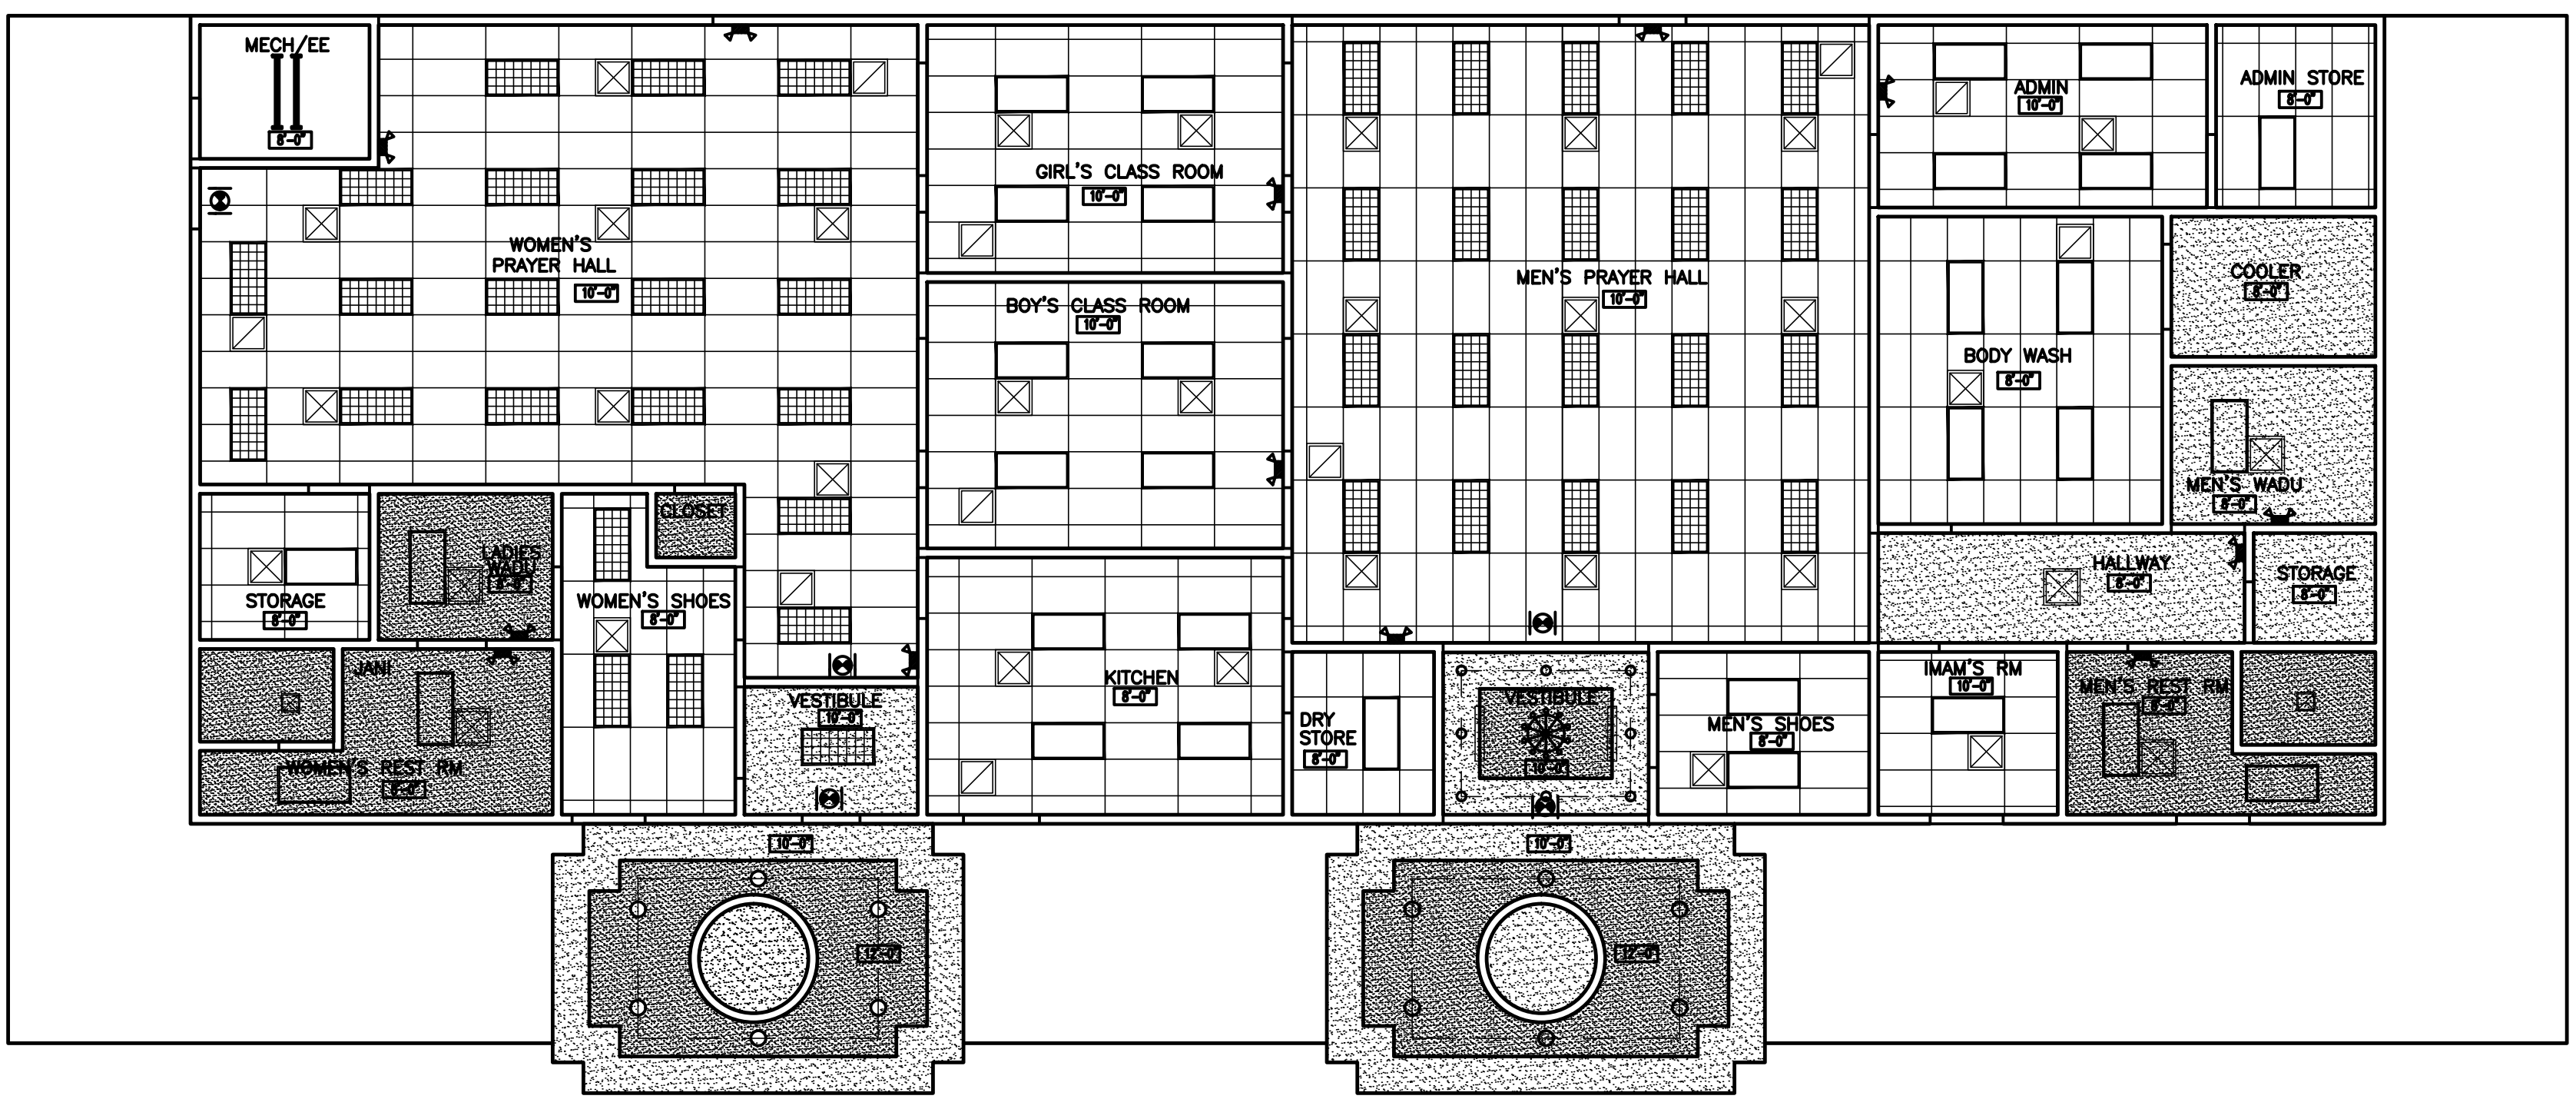

PLAN NORTH
01 REFLECTED CEILING PLAN
 SCALE: 1/8" = 1'-0"